


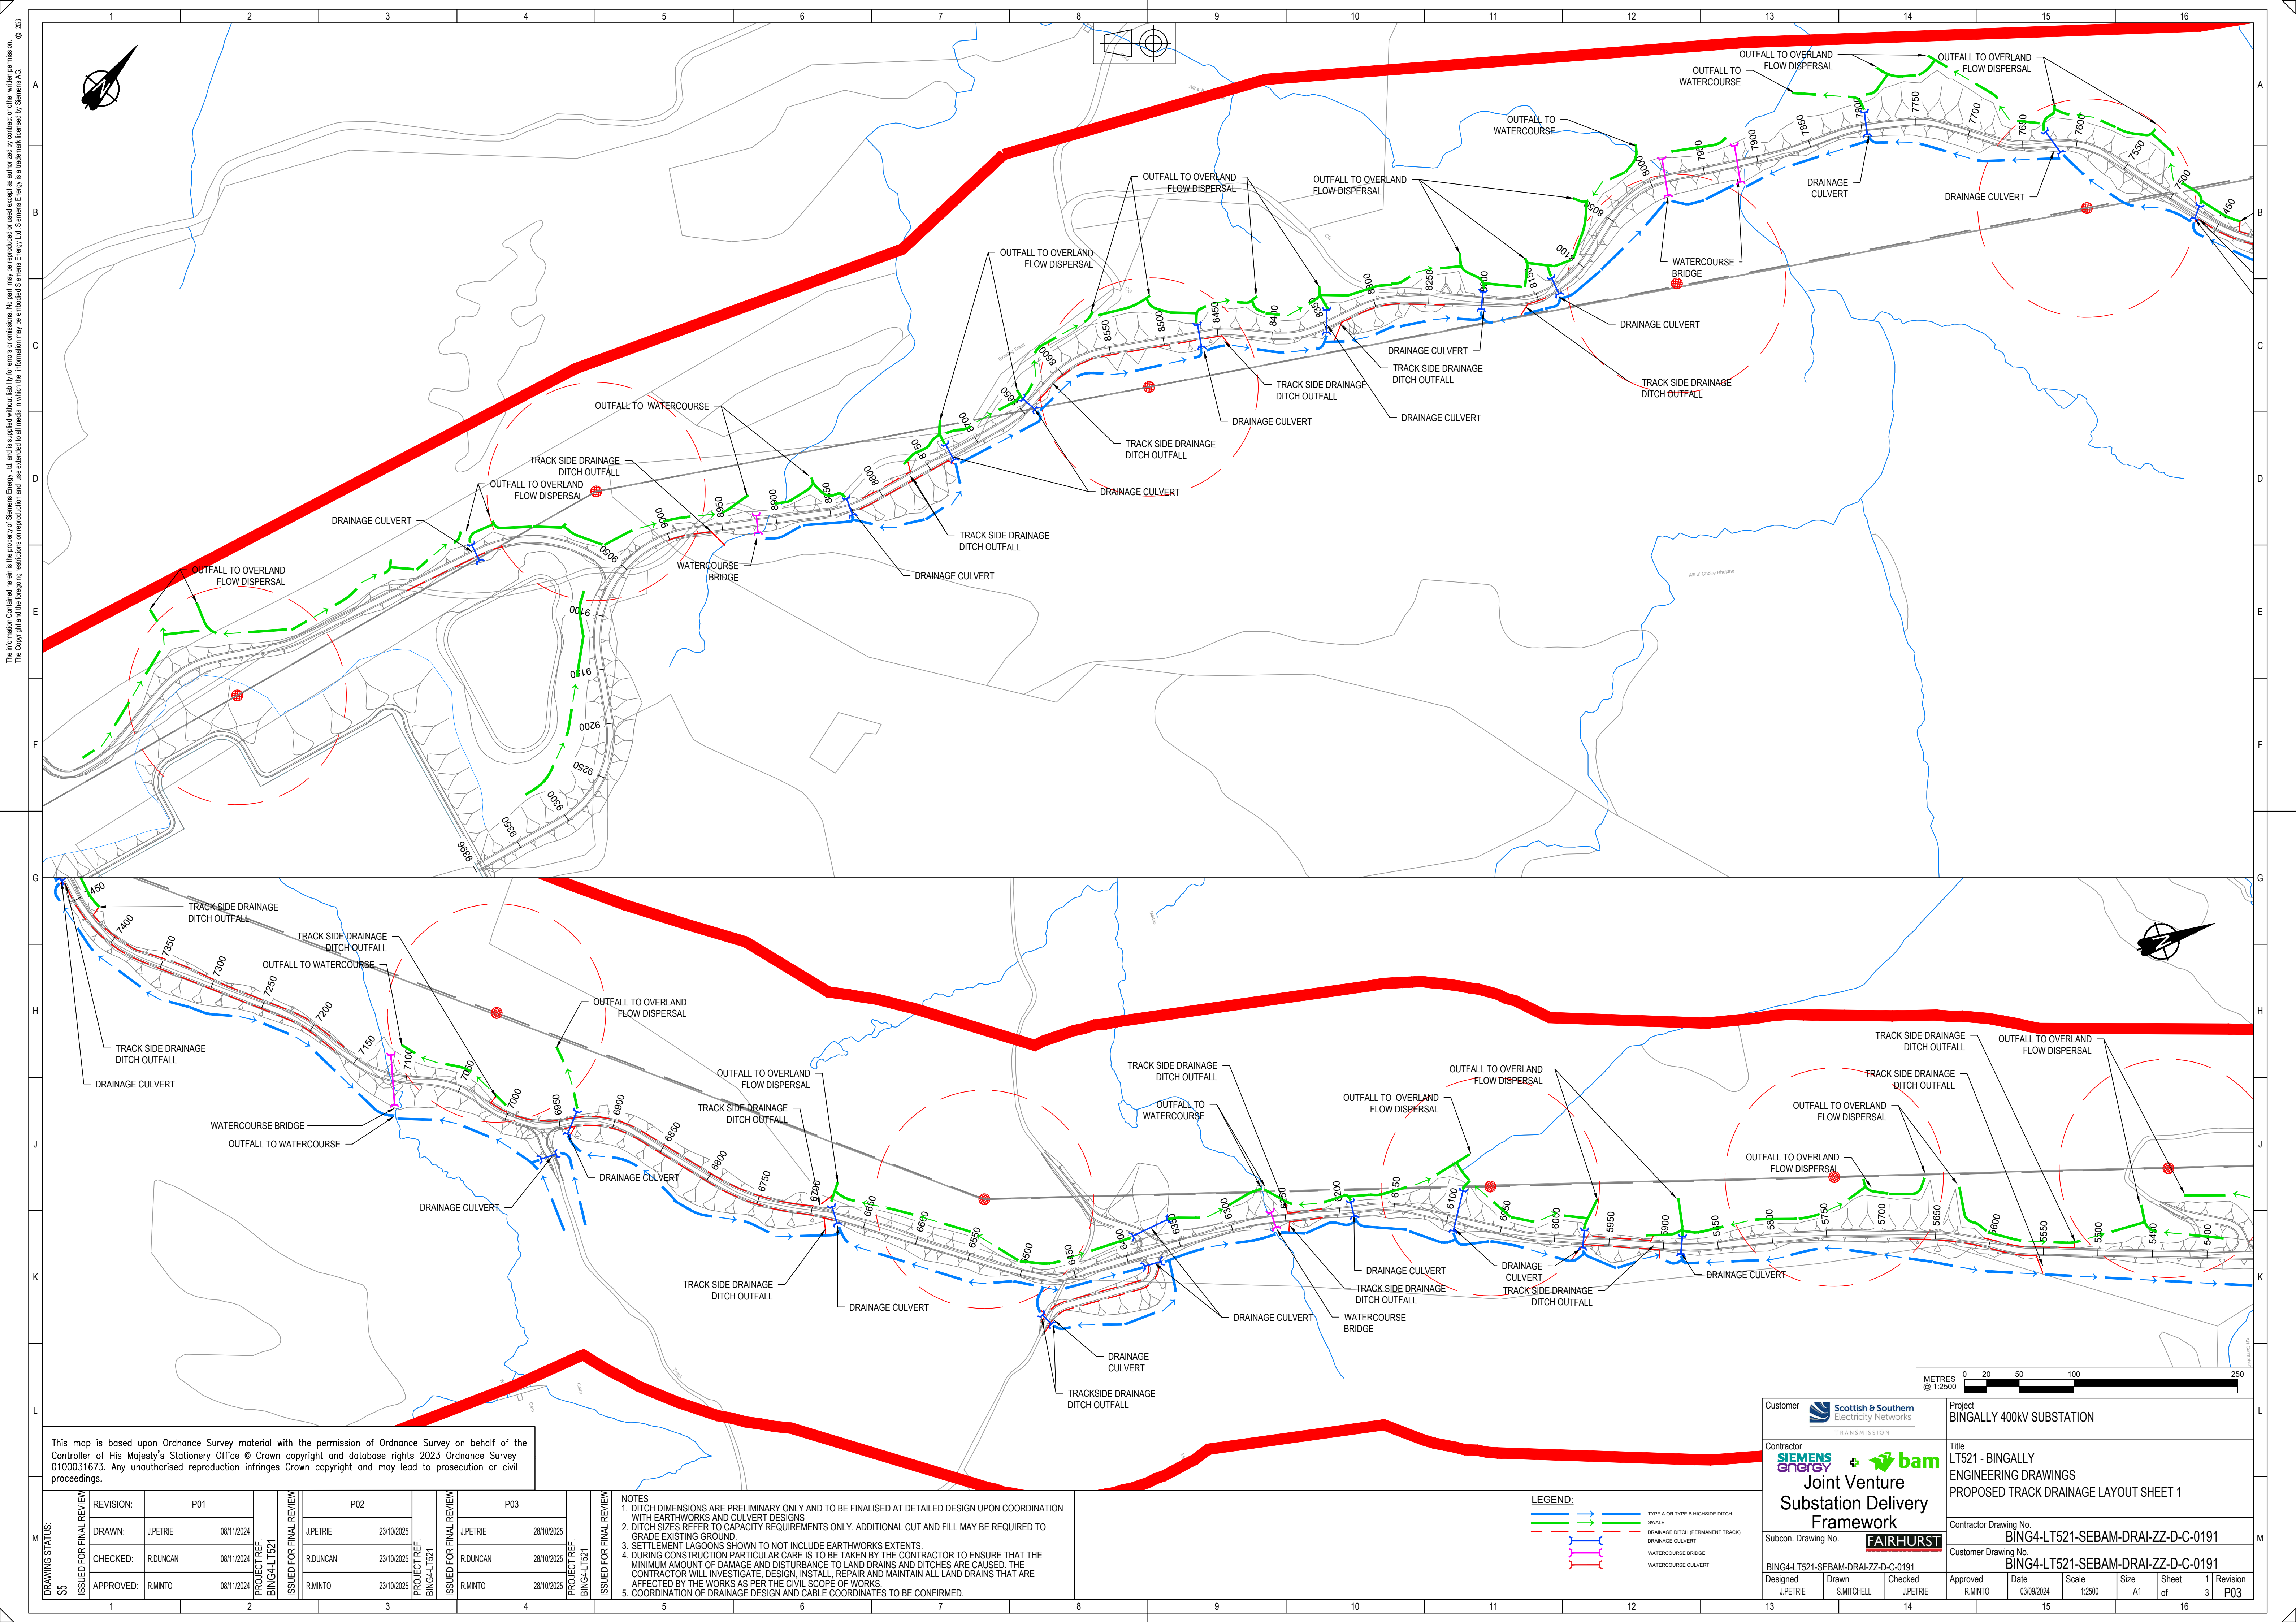

This map is based upon Ordnance Survey material with the permission of Ordnance Survey on behalf of the Controller of His Majesty's Stationary Office © Crown copyright and database rights 2023 Ordnance Survey 0100031673. Any unauthorised reproduction infringes Crown copyright and may lead to prosecution or civil proceedings.

DRAWING STATUS: SS	REVISION:	P01	PROJECT REF: BING4-LT521	P02	PROJECT REF: BING4-LT521	P03	PROJECT REF: BING4-LT521
	DRAWN:	J.PETRIE 08/11/2024		J.PETRIE 23/10/2025		J.PETRIE 28/10/2025	
	CHECKED:	R.DUNCAN 08/11/2025		R.DUNCAN 23/10/2025		R.DUNCAN 28/10/2025	
	APPROVED:	R.MINTO 08/11/2025		R.MINTO 23/10/2025		R.MINTO 28/10/2025	

- NOTES
1. DITCH DIMENSIONS ARE PRELIMINARY ONLY AND TO BE FINALISED AT DETAILED DESIGN UPON COORDINATION WITH EARTHWORKS AND CULVERT DESIGNS
 2. DITCH SIZES REFER TO CAPACITY REQUIREMENTS ONLY. ADDITIONAL CUT AND FILL MAY BE REQUIRED TO GRADE EXISTING GROUND.
 3. SETTLEMENT LAGOONS SHOWN TO NOT INCLUDE EARTHWORKS EXTENTS.
 4. DURING CONSTRUCTION PARTICULAR CARE IS TO BE TAKEN BY THE CONTRACTOR TO ENSURE THAT THE MINIMUM AMOUNT OF DAMAGE AND DISTURBANCE TO LAND DRAINS AND DITCHES ARE CAUSED. THE CONTRACTOR WILL INVESTIGATE, DESIGN, INSTALL, REPAIR AND MAINTAIN ALL LAND DRAINS THAT ARE AFFECTED BY THE WORKS AS PER THE CIVIL SCOPE OF WORKS
 5. COORDINATION OF DRAINAGE DESIGN AND CABLE COORDINATES TO BE CONFIRMED.

LEGEND:

- TYPE A OR TYPE B HIGHSIDE DITCH
- SHOULE
- DRAINAGE DITCH (PERMANENT TRACK)
- DRAINAGE CULVERT
- WATERCOURSE BRIDGE
- WATERCOURSE CULVERT

Customer	Scottish & Southern Electricity Networks TRANSMISSION	Project BINGALLY 400KV SUBSTATION
Contractor	SIEMENS energy + bam Joint Venture Substation Delivery Framework	Title LT521 - BINGALLY ENGINEERING DRAWINGS PROPOSED TRACK DRAINAGE LAYOUT SHEET 1
Subcon: Drawing No.	FAIRHURST	Contractor Drawing No. BING4-LT521-SEBAM-DRAI-ZZ-D-C-0191
BING4-LT521-SEBAM-DRAI-ZZ-D-C-0191	Designed J.PETRIE	Customer Drawing No. BING4-LT521-SEBAM-DRAI-ZZ-D-C-0191
Drawn S.MITCHELL	Checked J.PETRIE	Approved R.MINTO
Date 03/09/2024	Scale 1:2500	Size A1
Sheet of 3	1 Revision P03	