


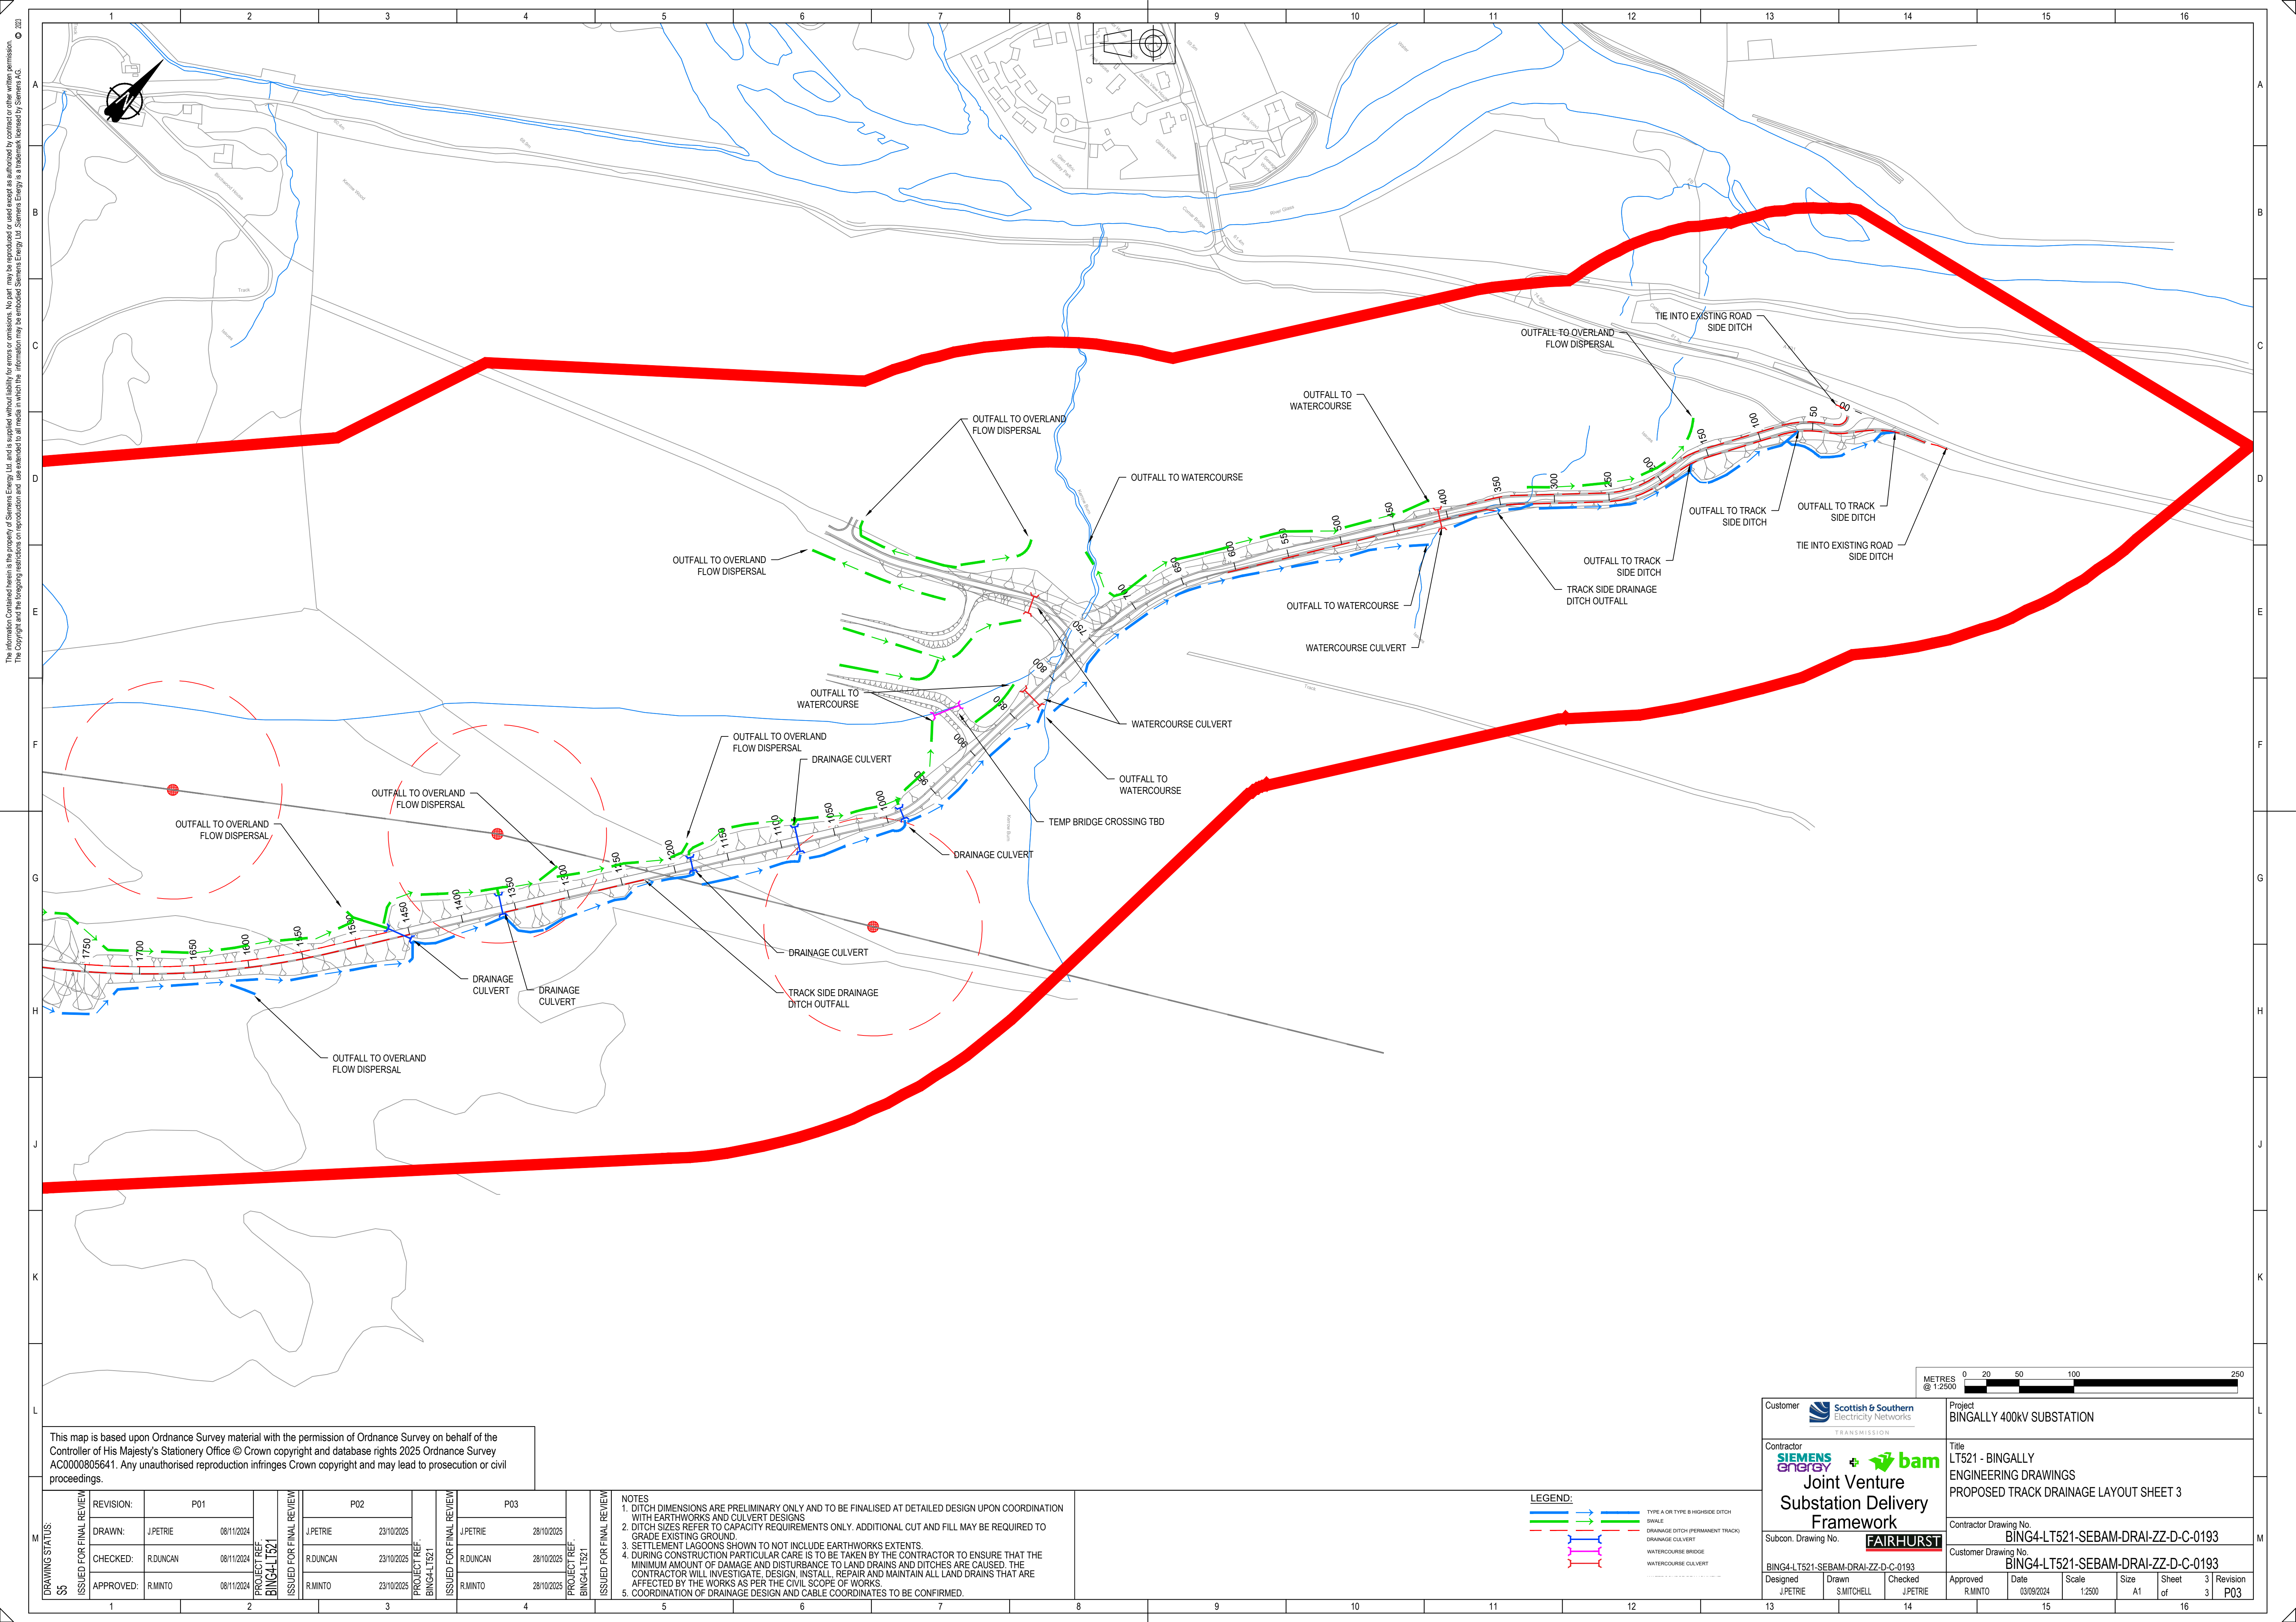

This map is based upon Ordnance Survey material with the permission of Ordnance Survey on behalf of the Controller of His Majesty's Stationery Office © Crown copyright and database rights 2025 Ordnance Survey AC0000805641. Any unauthorised reproduction infringes Crown copyright and may lead to prosecution or civil proceedings.

DRAWING STATUS: SS	REVISION:	P01		PROJECT REF: BING4-LT521 ISSUED FOR FINAL REVIEW	P02		PROJECT REF: BING4-LT521 ISSUED FOR FINAL REVIEW	P03		PROJECT REF: BING4-LT521 ISSUED FOR FINAL REVIEW
	DRAWN:	J.PETRIE	08/11/2024		J.PETRIE	23/10/2025		J.PETRIE	28/10/2025	
	CHECKED:	R.DUNCAN	08/11/2024		R.DUNCAN	23/10/2025		R.DUNCAN	28/10/2025	
	APPROVED:	R.MINTO	08/11/2024		R.MINTO	23/10/2025		R.MINTO	28/10/2025	
1	2	3	4	5	6	7	8	9	10	11

- NOTES
1. DITCH DIMENSIONS ARE PRELIMINARY ONLY AND TO BE FINALISED AT DETAILED DESIGN UPON COORDINATION WITH EARTHWORKS AND CULVERT DESIGNS
 2. DITCH SIZES REFER TO CAPACITY REQUIREMENTS ONLY. ADDITIONAL CUT AND FILL MAY BE REQUIRED TO GRADE EXISTING GROUND.
 3. SETTLEMENT LAGOONS SHOWN TO NOT INCLUDE EARTHWORKS EXTENTS.
 4. DURING CONSTRUCTION PARTICULAR CARE IS TO BE TAKEN BY THE CONTRACTOR TO ENSURE THAT THE MINIMUM AMOUNT OF DAMAGE AND DISTURBANCE TO LAND DRAINS AND DITCHES ARE CAUSED. THE CONTRACTOR WILL INVESTIGATE, DESIGN, INSTALL, REPAIR AND MAINTAIN ALL LAND DRAINS THAT ARE AFFECTED BY THE WORKS AS PER THE CIVIL SCOPE OF WORKS
 5. COORDINATION OF DRAINAGE DESIGN AND CABLE COORDINATES TO BE CONFIRMED.

LEGEND:

- TYPE A OR TYPE B HIGHSIDE DITCH
- SWALE
- DRAINAGE DITCH (PERMANENT TRACK)
- DRAINAGE CULVERT
- WATERCOURSE BRIDGE
- WATERCOURSE CULVERT

Customer

TRANSMISSION

Contractor

Joint Venture
Substation Delivery
Framework

Subcon: Drawing No.

BING4-LT521-SEBAM-DRAI-ZZ-D-C-0193

Designed J.PETRIE
Drawn S.MITCHELL
Checked J.PETRIE

Project

BINGALLY 400kV SUBSTATION

Title

LT521 - BINGALLY
ENGINEERING DRAWINGS
PROPOSED TRACK DRAINAGE LAYOUT SHEET 3

Contractor Drawing No.

BING4-LT521-SEBAM-DRAI-ZZ-D-C-0193

Customer Drawing No.

BING4-LT521-SEBAM-DRAI-ZZ-D-C-0193

Approved R.MINTO

Date 03/09/2024

Scale 1:2500

Size A1

Sheet 3 of 3

Revision P03