




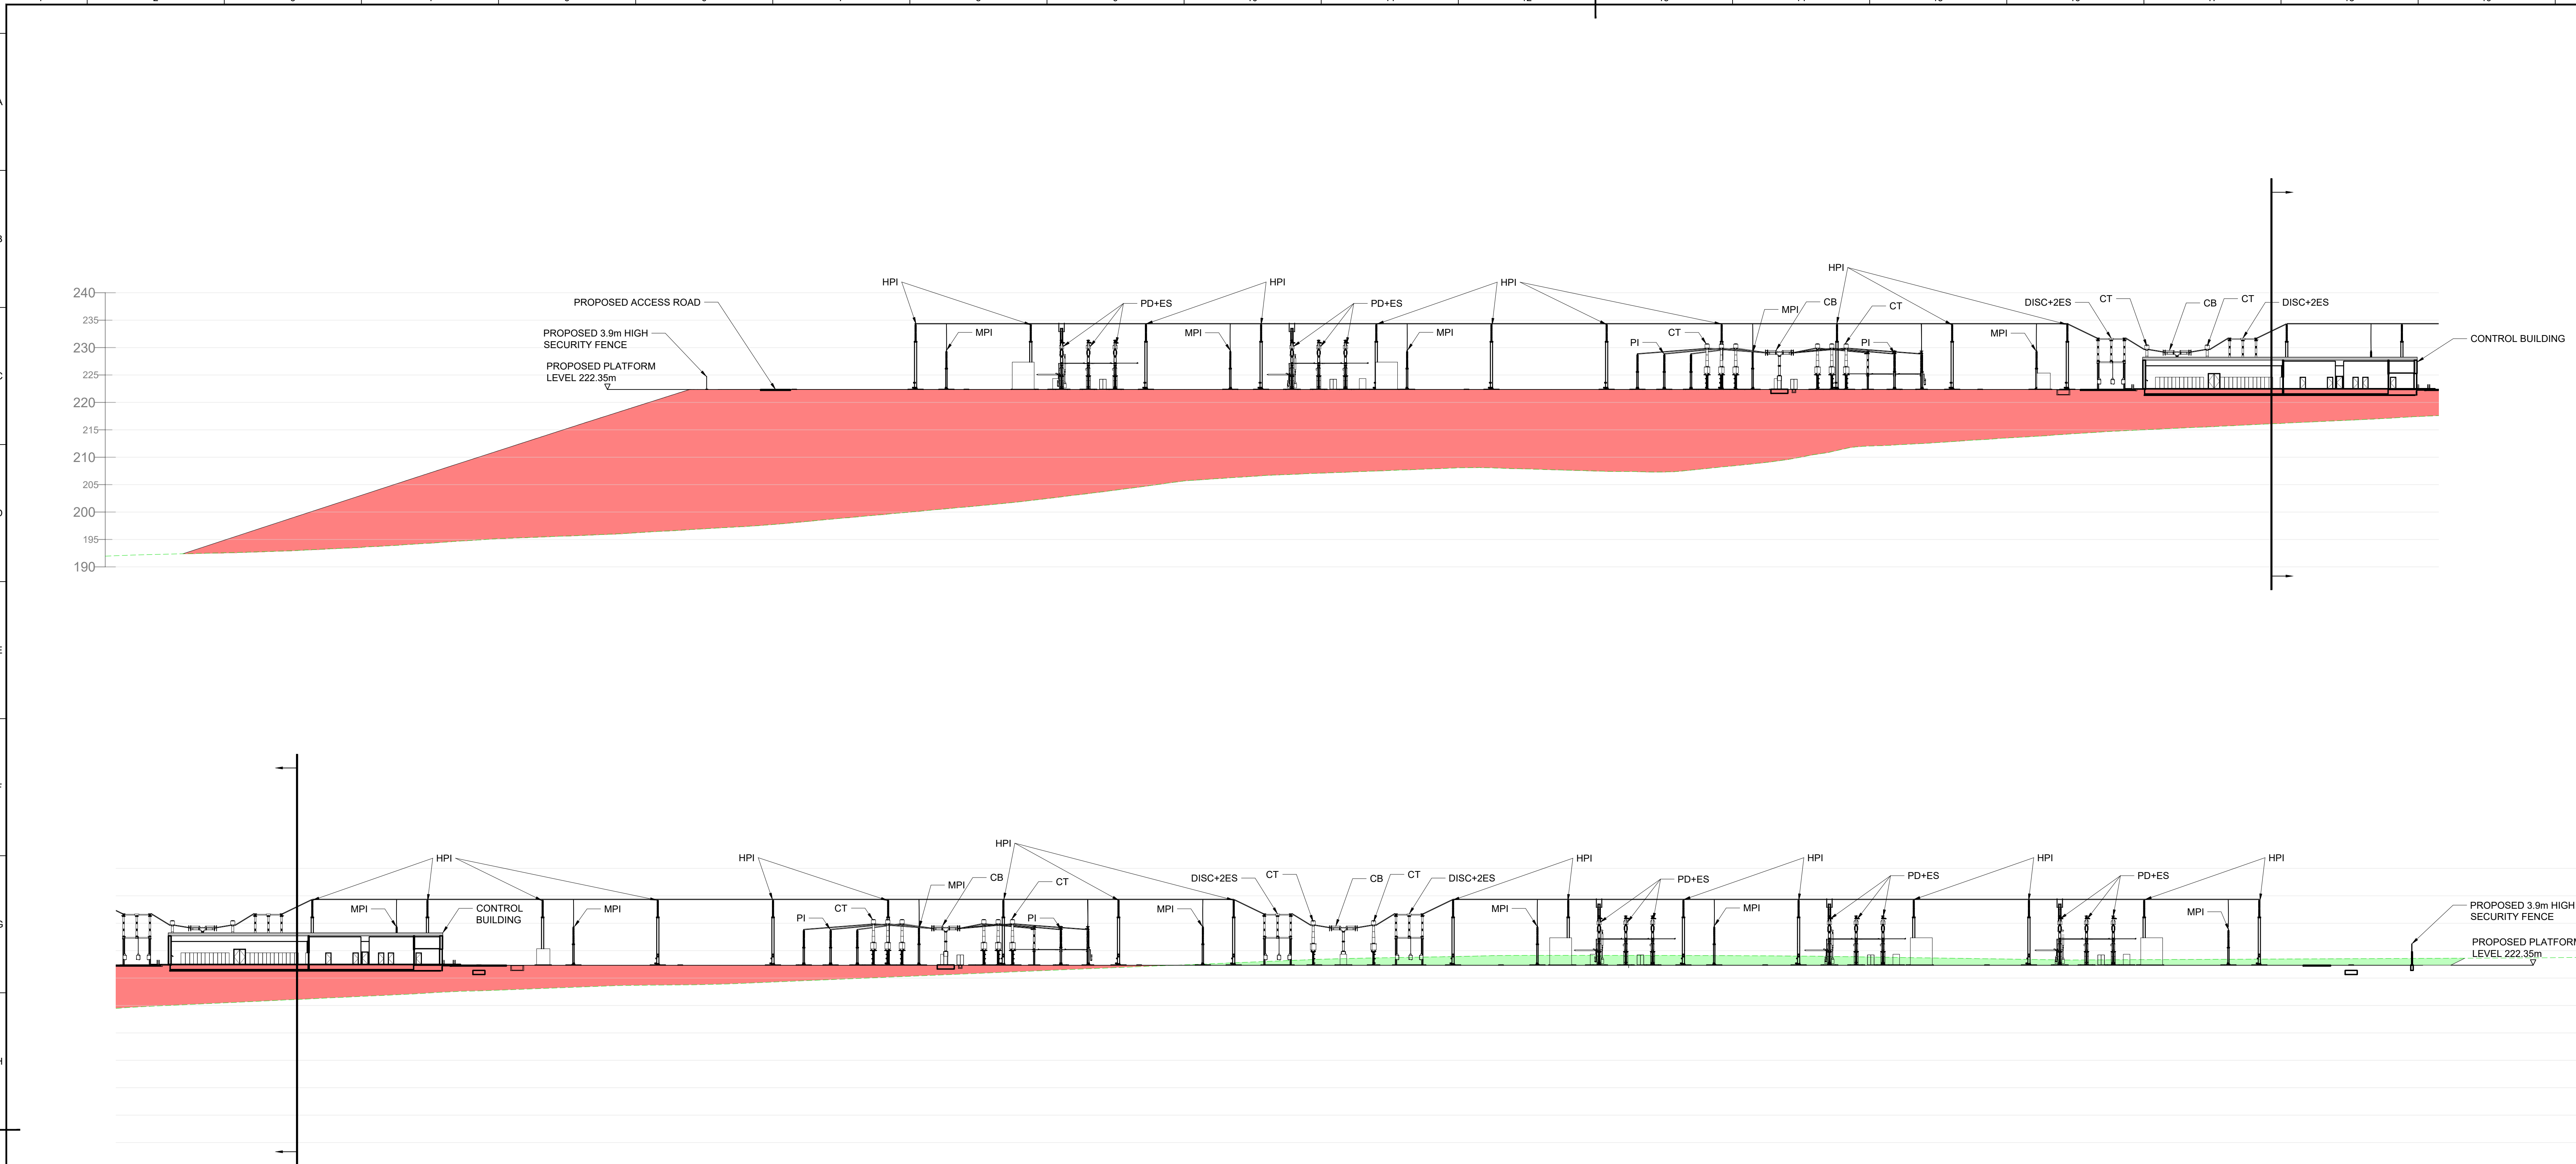

SECTION C-C
SCALE 1:500

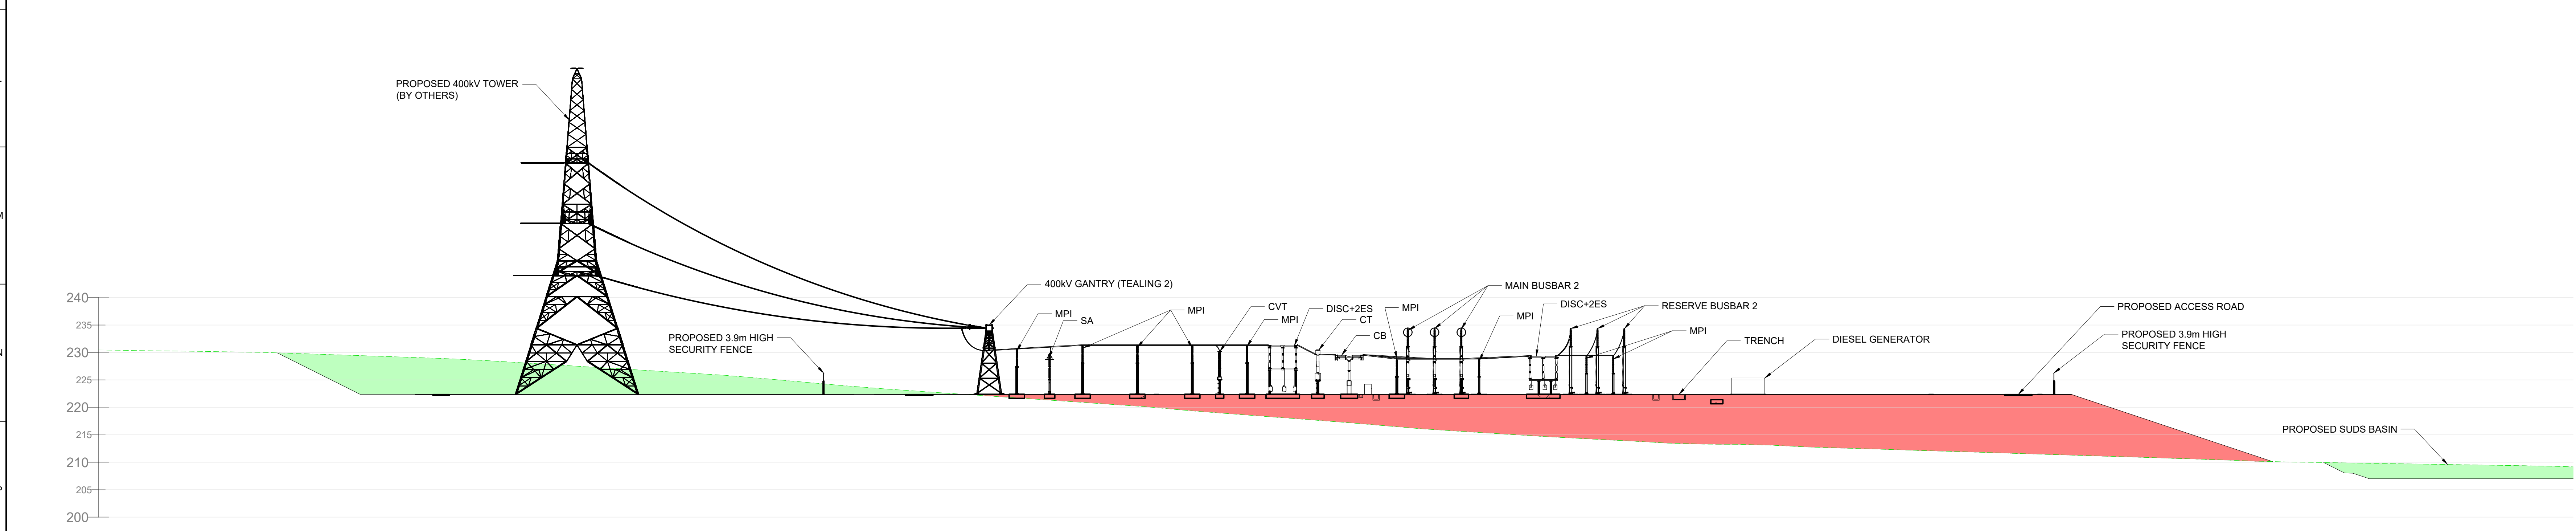

SECTION D-D
SCALE 1:500

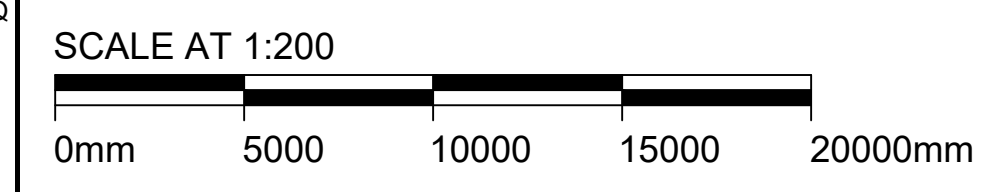

Issue / Revision:	P01	Drawn By:	CN	Issue / Revision:	P02	Drawn By:	CN
Investment No.:		Checked By:	RC	Investment No.:		Checked By:	SD
Date:	21/NOV/24	Approved By:	PM	Date:	10/APR/25	Approved By:	
Description / Remarks ISSUED FOR PLANNING				Description / Remarks UPDATED KEY PLAN FOR SECTION E-E			


- NOTES:**
- DO NOT SCALE FROM THIS DRAWING. USE ONLY SPECIFIED DIMENSIONS.
 - ALL LEVELS ARE IN METRES TO ORDNANCE DATUM UNLESS NOTED OTHERWISE.

REFERENCE DRAWINGS:

162507-BMD-CE-HR-DSE-TP-0001
162507-BMD-PL-HR-DPL-TP-0001

PLATFORM EARTHWORKS LAYOUT
ELECTRICAL LAYOUT

- LEGEND:**
- EXISTING TERRAIN
 - CUT AREA
 - FILL AREA

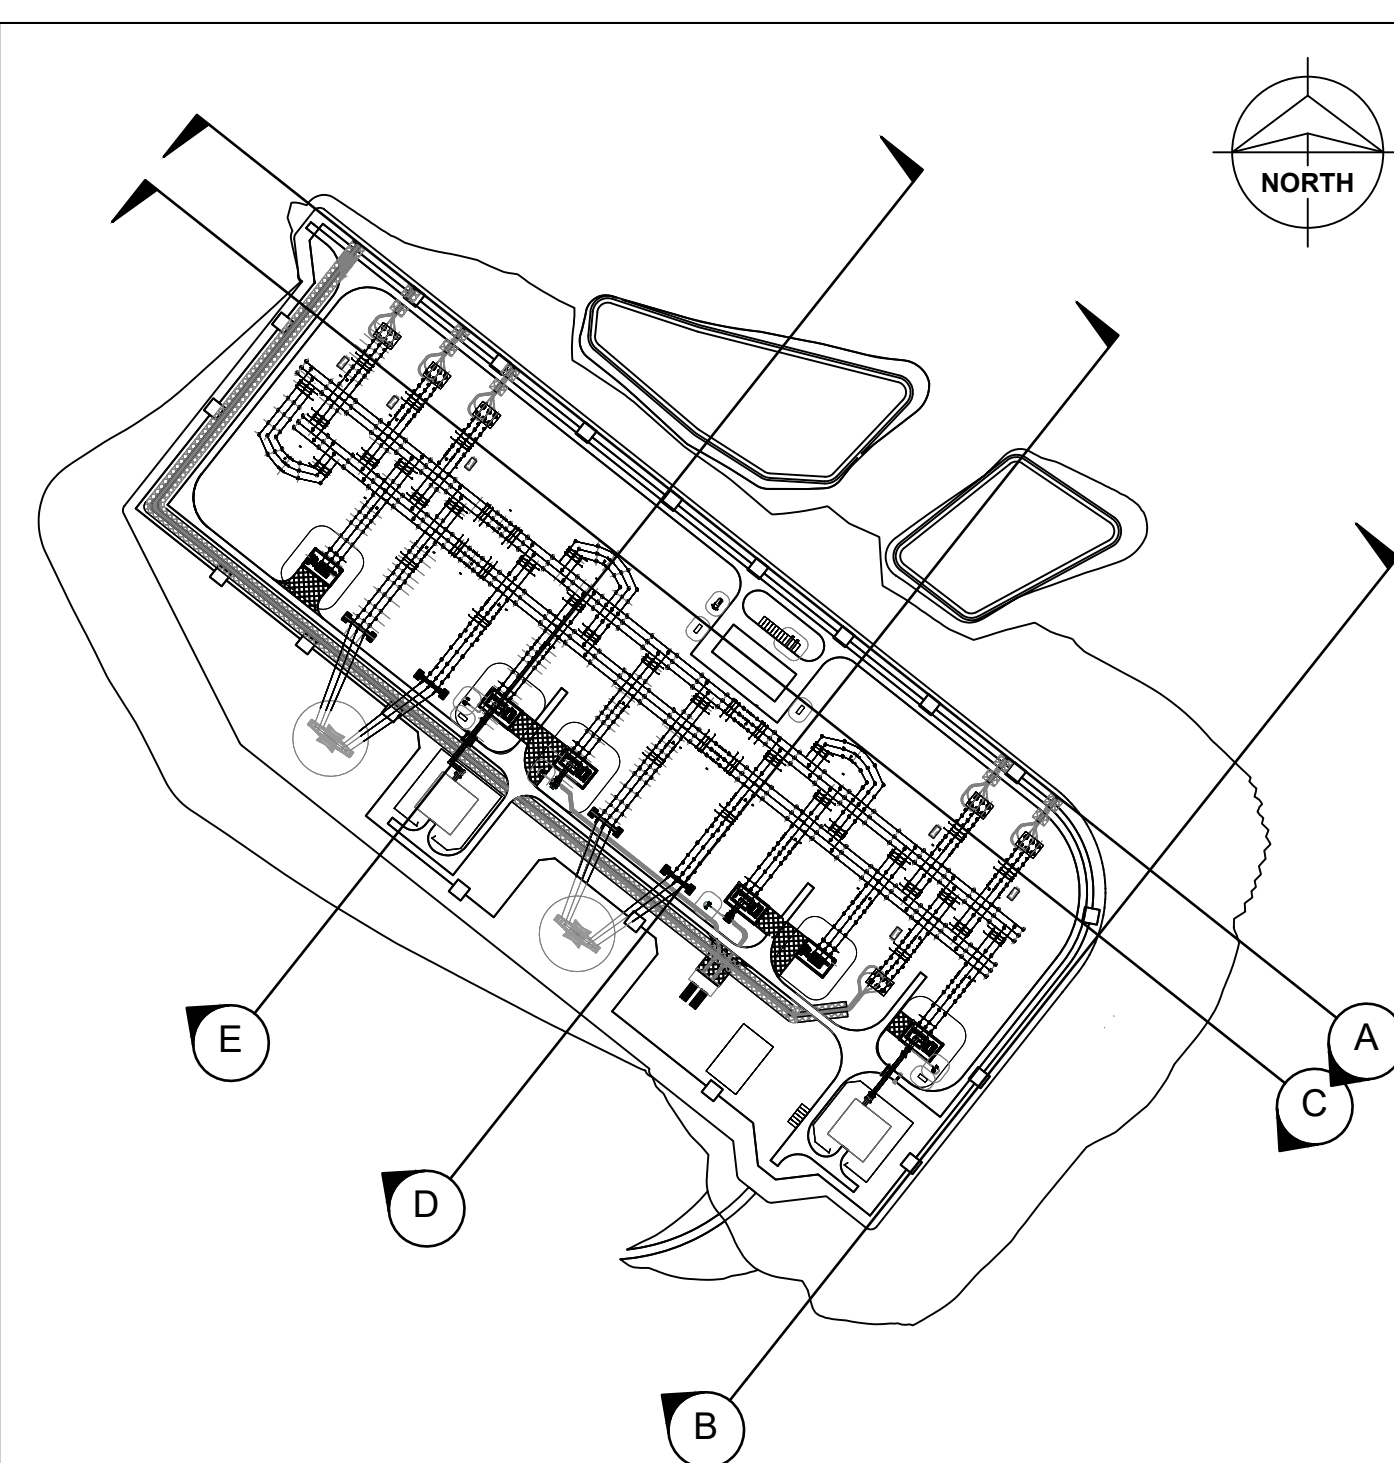

KEY PLAN
SCALE 1:5000

- KEY:**
- SA - SURGE ARRESTER
 - PI - POST INSULATOR
 - MPI - MEDIUM LEVEL POST INSULATOR
 - HPI - HIGH LEVEL POST INSULATOR
 - CT - CURRENT TRANSFORMER
 - CVT - CAPACITIVE VOLTAGE TRANSFORMER
 - CB - CIRCUIT BREAKER
 - DISC+2ES - DISCONNECTOR WITH TWO EARTH SWITCH
 - PD+ES - PANTOGRAPH WITH EARTH SWITCH
 - SGT - SUPERGRID TRANSFORMER

Drawing Status: FOR PLANNING			
Software: AUTOCAD	Status Code: Not Used	Scale: 1:500	Paper Size: A0
Drawn By: CN	Checked By: RC	Approved By: PM	Date: 21/NOV/2
Contractor: BURNS & McDONNELL Burns & McDonnell Europe (UK) Limited, trading as Burns & McDonnell 2 Parkside Way, Macclesfield, Cheshire, M13 9PL, UK Email: enquiry@burnsmod.com Website: www.burnsmod.com			
Client:  Scottish & Southern Electricity Networks		Supplier / Subcontractor:	
Drawing Title: SITE SECTIONS			
Project Name: HURLIE 400kV SUBSTATION			
Site Name: HURLIE 400kV SUBSTATION			
Contractor Drawing No.: 162507-BMD-CE-HR-DEL-TP-0004			
Client Drawing No.: 162507-BMD-CE-HR-DEL-TP-0004		Sheet: 02	Next: 03
Supplier / Subcontractor Drawing No.: -		Issue / Revision: P02	