



SECTION E-E
SCALE 1:500

- NOTES:**
- DO NOT SCALE FROM THIS DRAWING. USE ONLY SPECIFIED DIMENSIONS.
 - ALL LEVELS ARE IN METRES TO ORDNANCE DATUM UNLESS NOTED OTHERWISE.
- REFERENCE DRAWINGS:**
- | | |
|------------------------------|----------------------------|
| 162507-BMD-CE-HR-DSE-TP-0001 | PLATFORM EARTHWORKS LAYOUT |
| 162507-BMD-PL-HR-DPL-TP-0001 | ELECTRICAL LAYOUT |

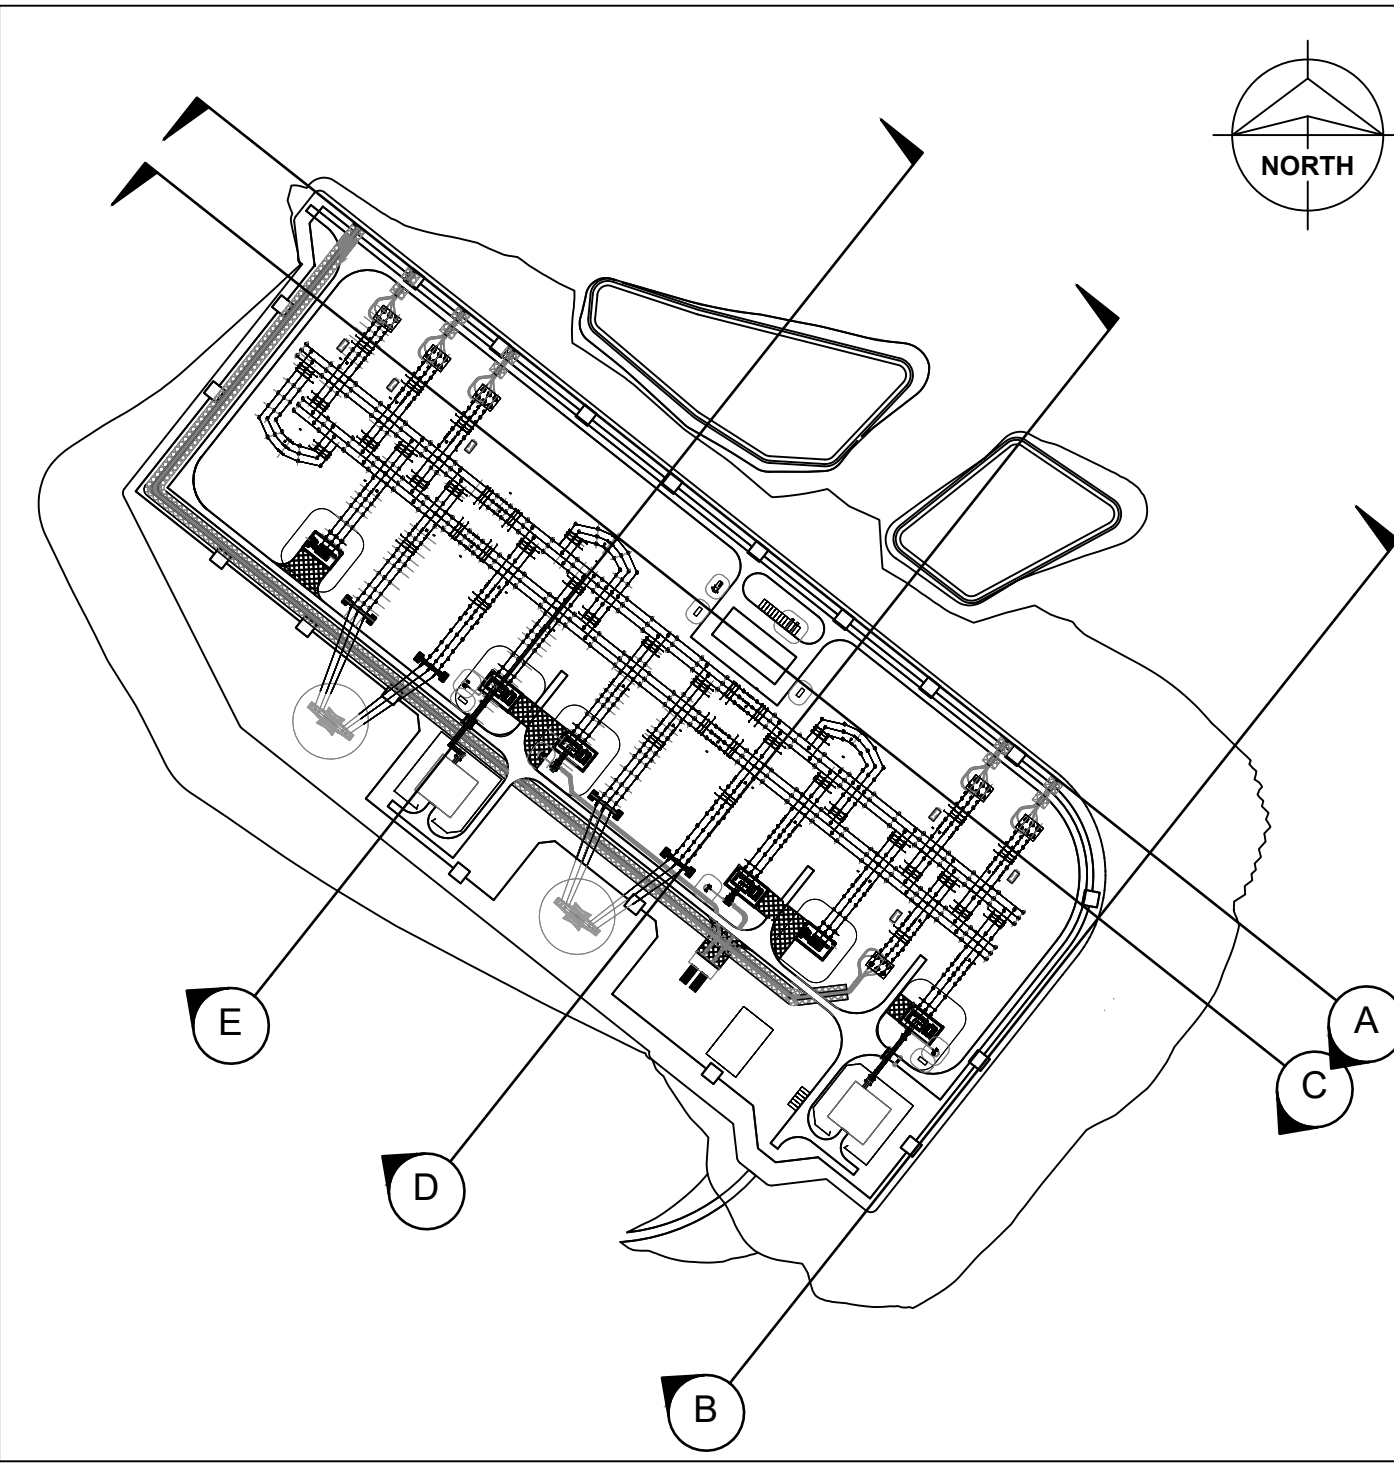

KEY PLAN
SCALE 1:5000

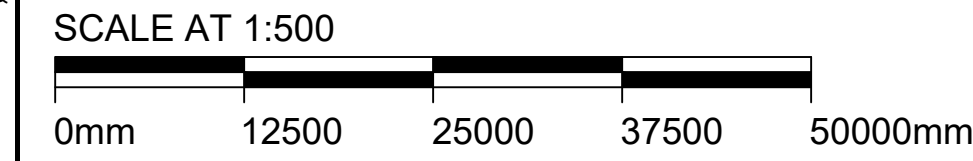

Issue / Revision:	P01	Drawn By:	CN
Investment No.:		Checked By:	SD
Date:	10/APR/25	Approved By:	
Description / Remarks			
ISSUED FOR PLANNING			

Drawing Status:			
FOR PLANNING			
Software:	Status Code:	Scale:	Paper Size:
AUTOCAD	Not Used	1:500	A0
Drawn By:	Checked By:	Approved By:	Date:
CN	RC	PM	21/NOV/24

Contractor:

BURNS & McDONNELL

Burns & McDonnell Europe (UK) Limited, trading as Burns & McDonnell
2 Parkside Way, Moorn Park, Motherwell, ML1 4QR, UK
Email: info@burns-mod.com Website: www.burnsmcd.com

Client:	Supplier / Subcontractor:

Drawing Title:
SITE SECTIONS

Project Name:
HURLIE 400kV SUBSTATION

Site Name:
HURLIE 400kV SUBSTATION

Contractor Drawing No.:
162507-BMD-CE-HR-DEL-TP-0006

Client Drawing No.:	Sheet:
162507-BMD-CE-HR-DEL-TP-0006	03
Supplier / Subcontractor Drawing No.:	Next:
-	
	Issue / Revision:
	P01