


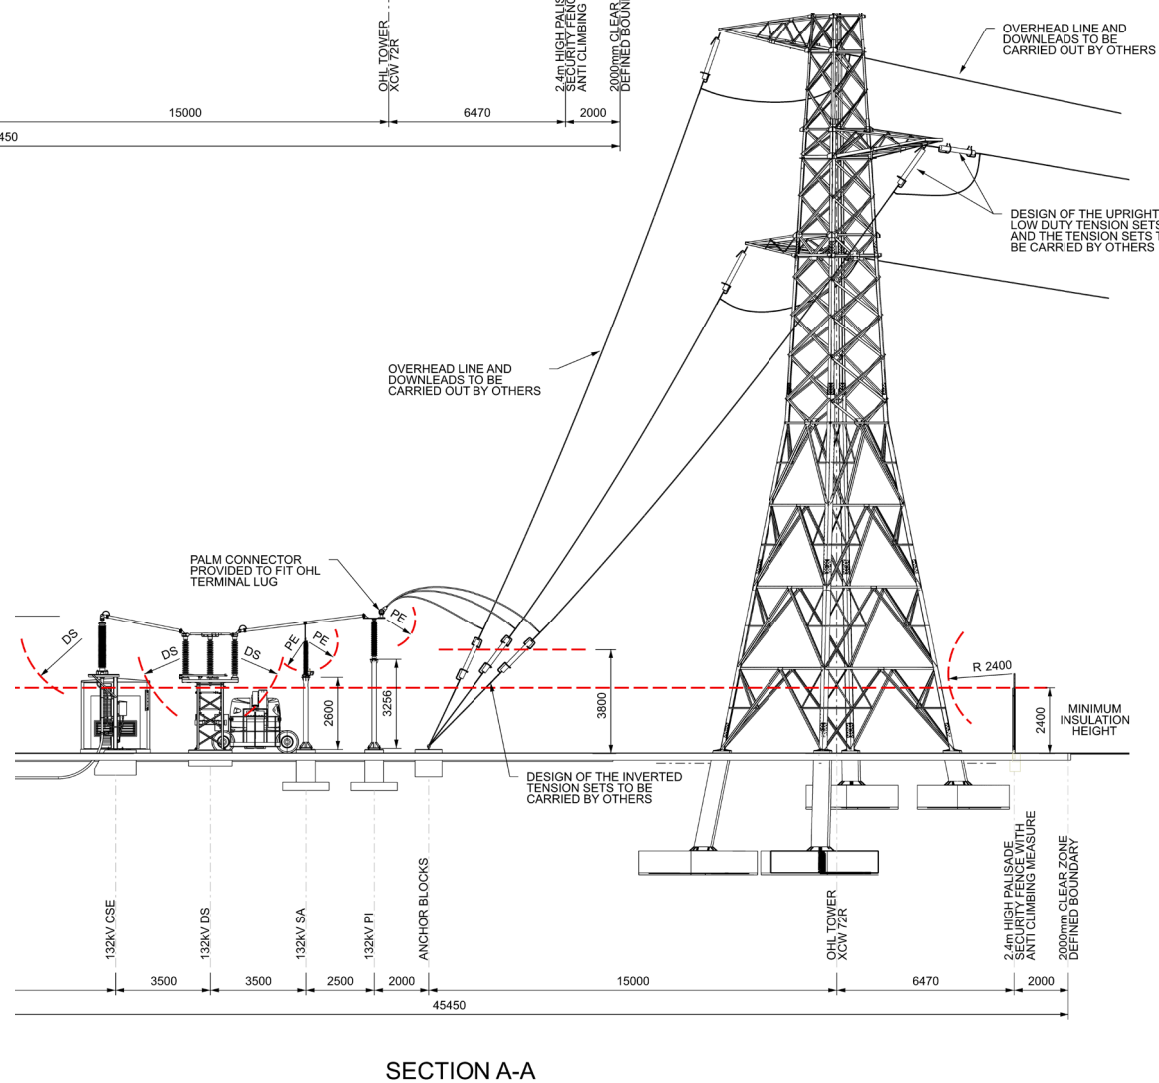
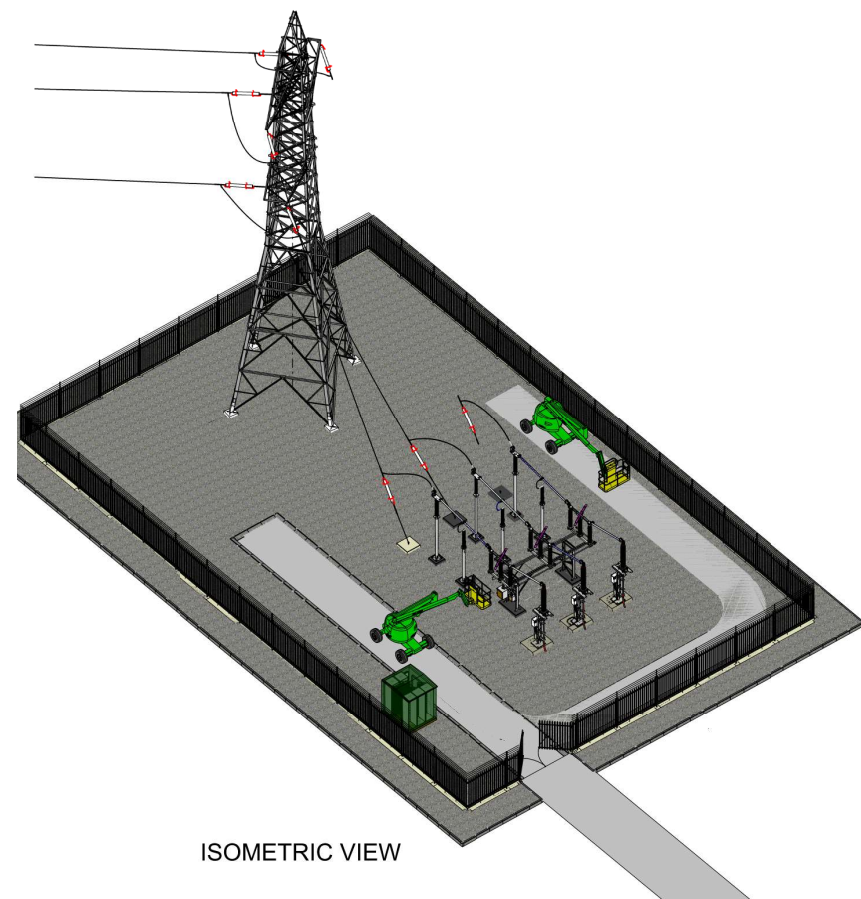
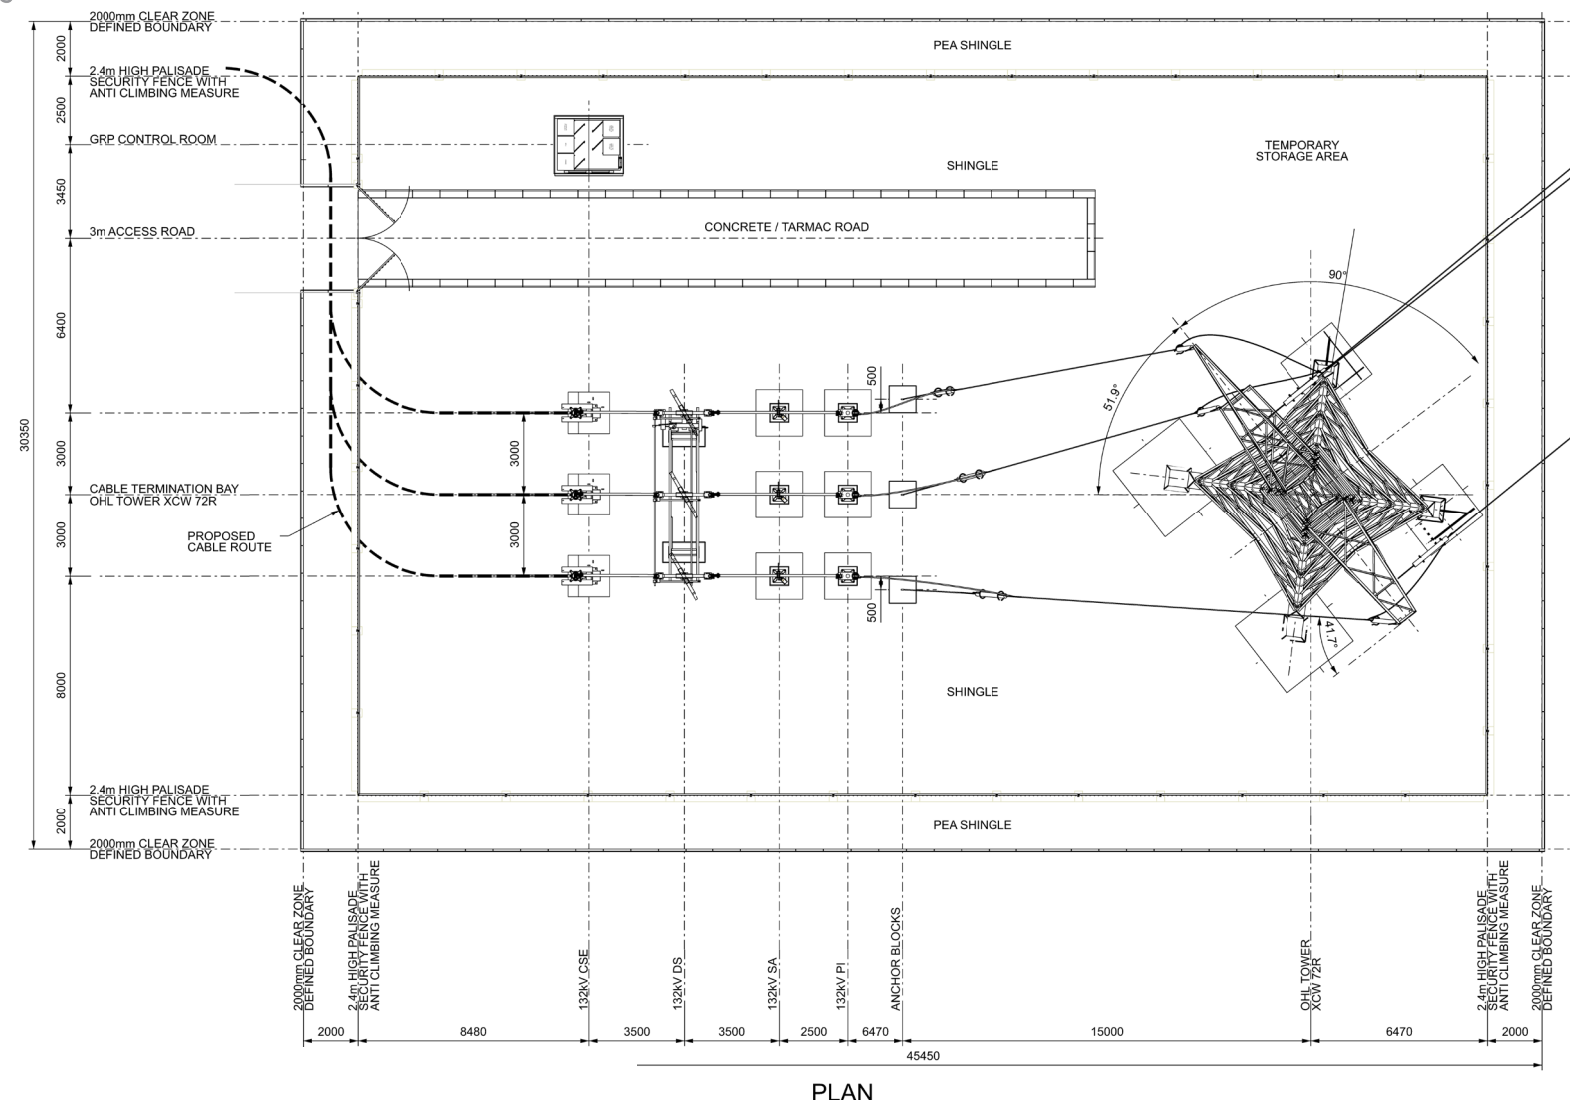


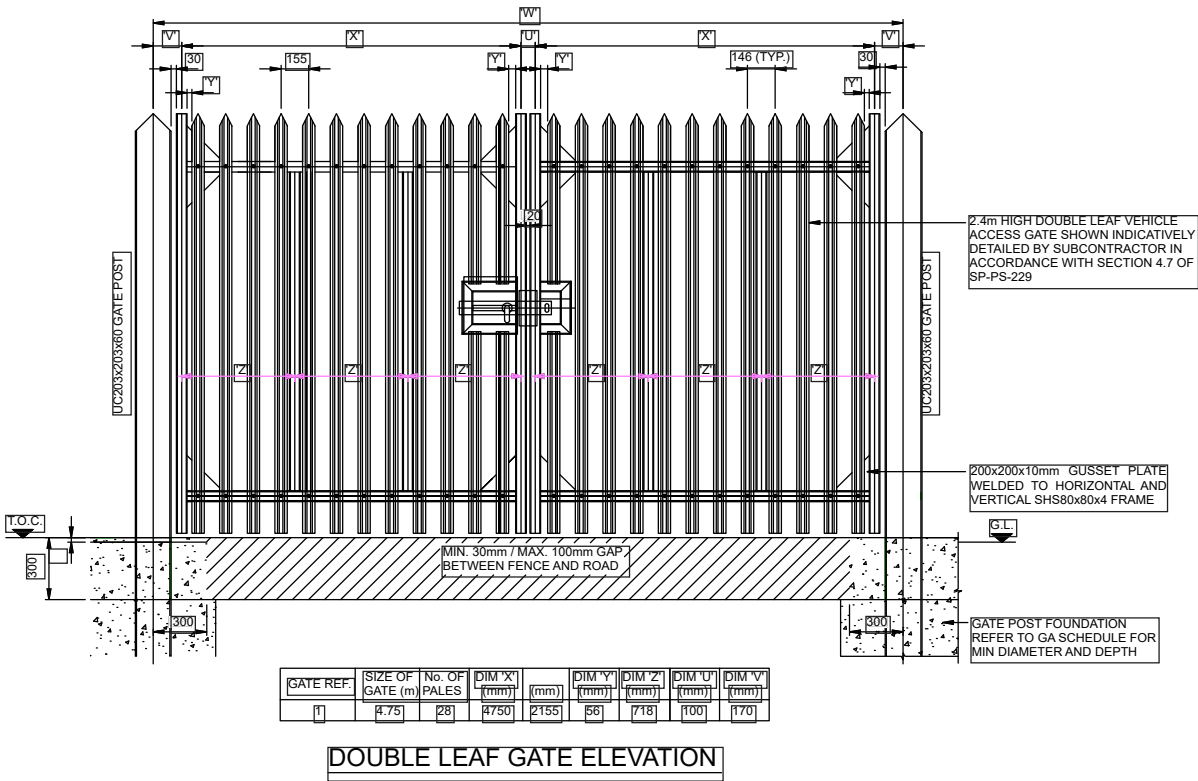

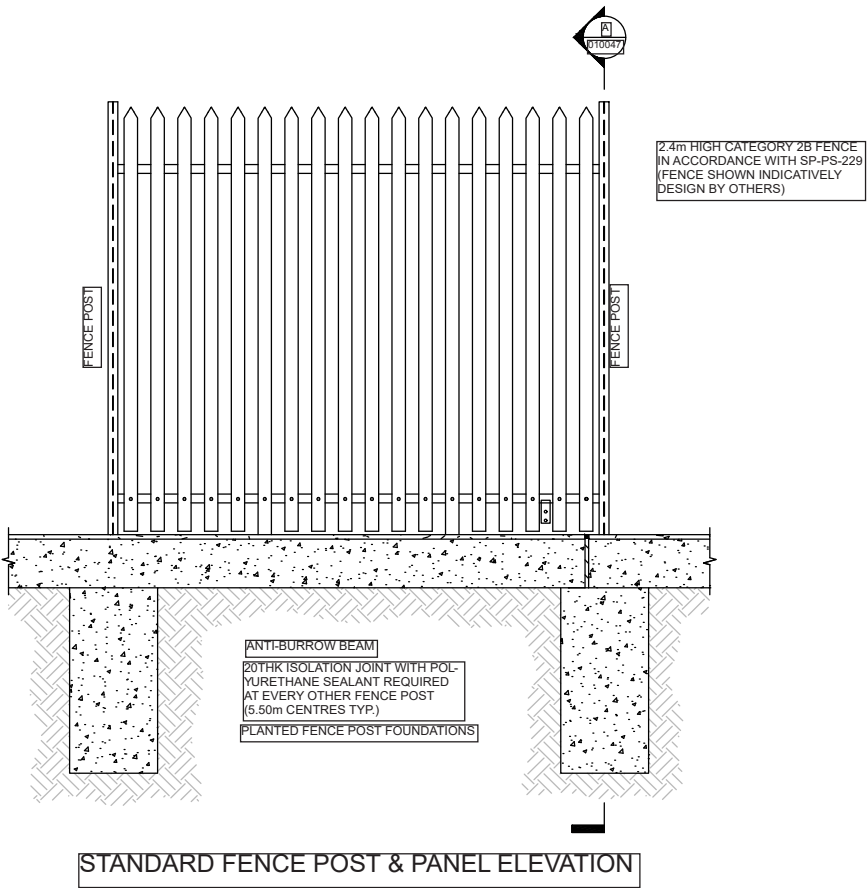

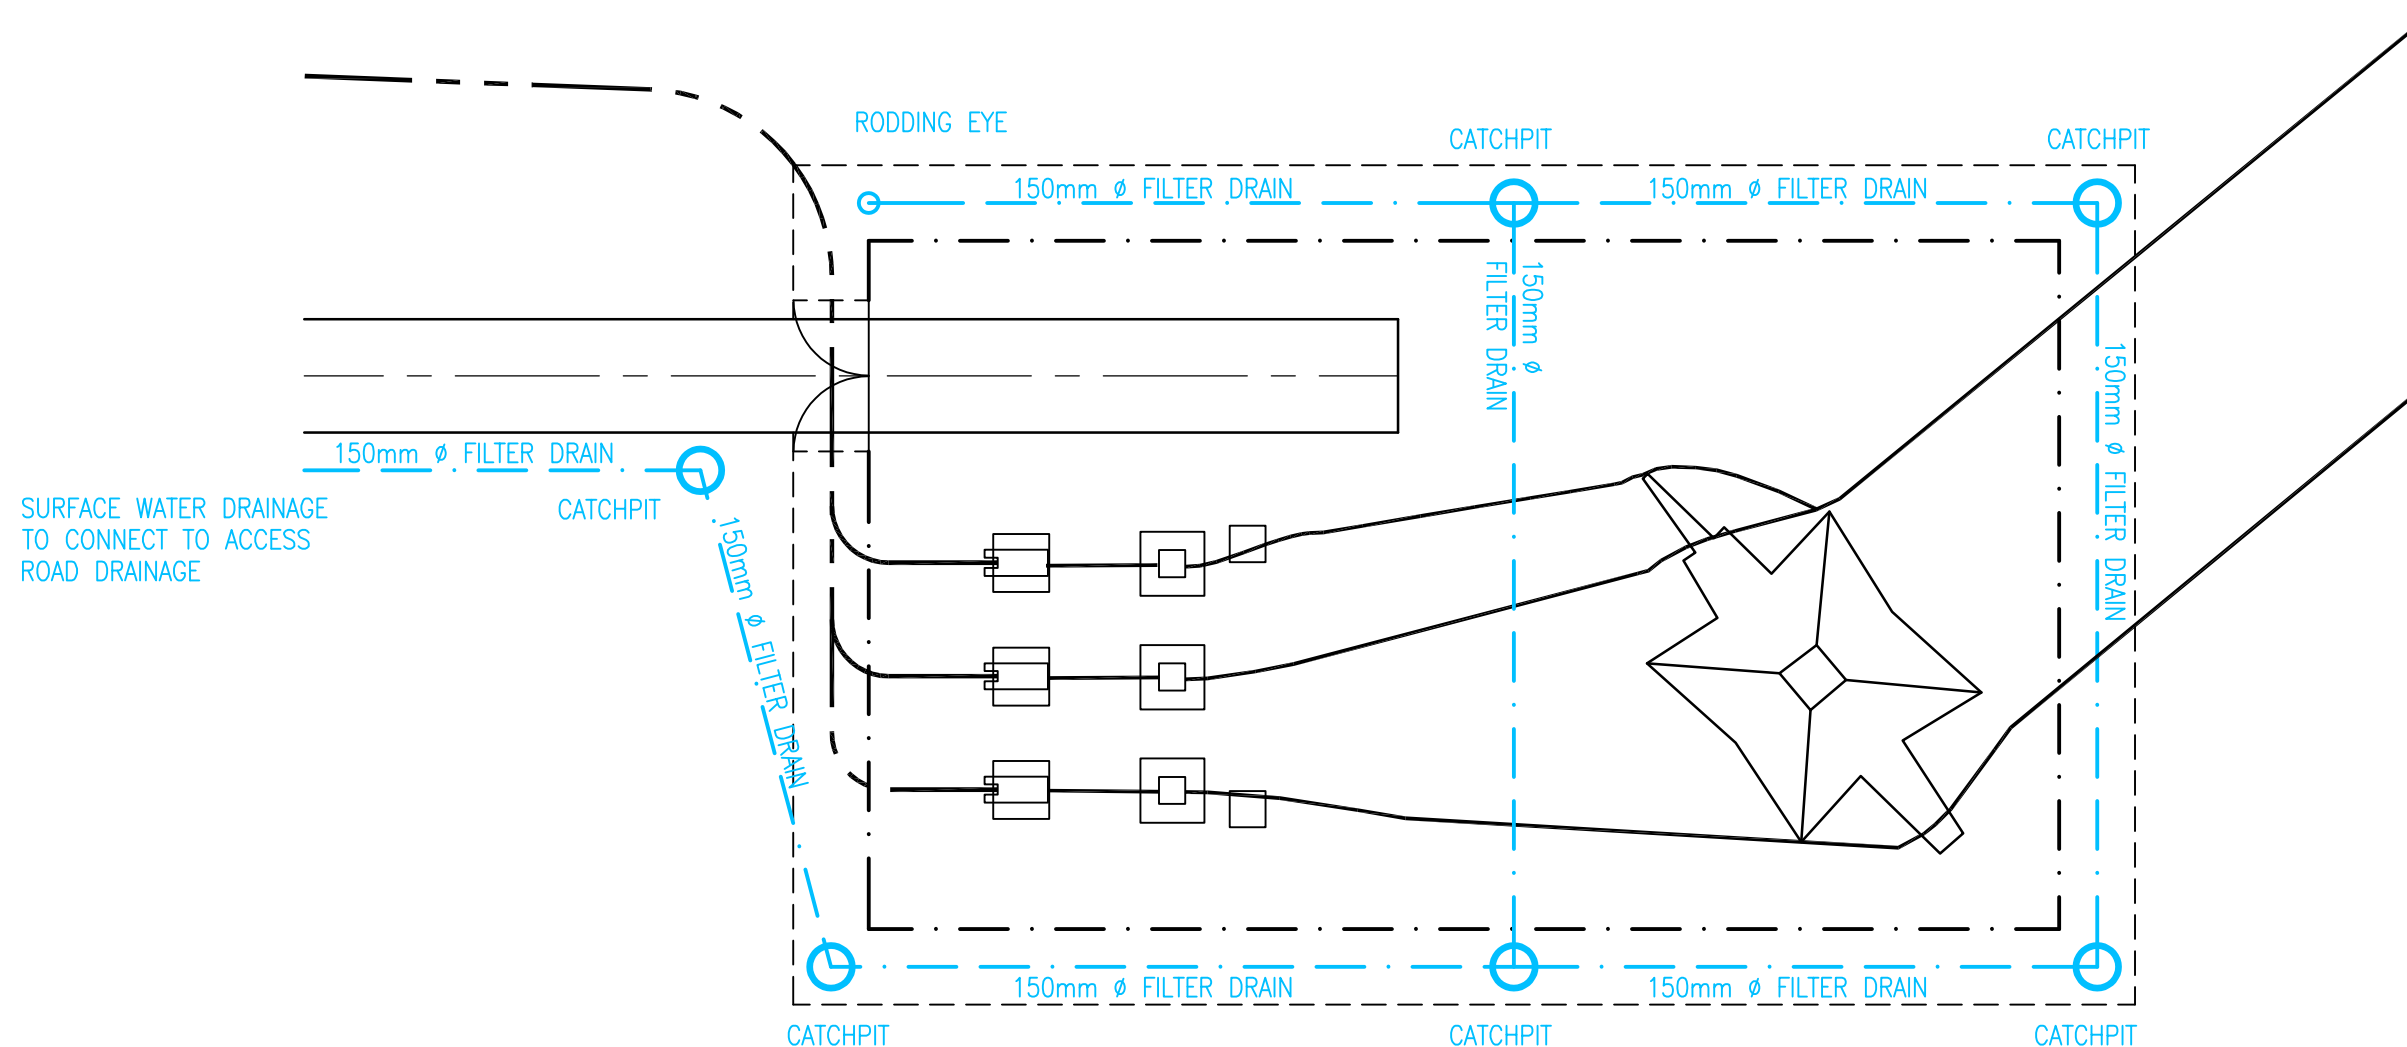

SEALING END COMPOUND DRAINAGE LAYOUT

Note: It is proposed that any drainage design required will be undertaken as works ancillary to the Proposed Development; accordingly, deemed planning permission is sought for these works under *Section 57(2) of the Town and Country Planning (Scotland) Act 1997*. The Applicant considers that details of the works, and detailed construction designs could be appropriately secured at a future time by way of planning condition requiring the further approval of the Planning Authority.

Project No: LT455

Project: Kintore to Tealing 400 kV Overhead Line

Title:

Indicative Cable Sealing End Compound Design

Drawn by: SR

Date: 19/08/2025

Drawing:	3.5c
----------	------